


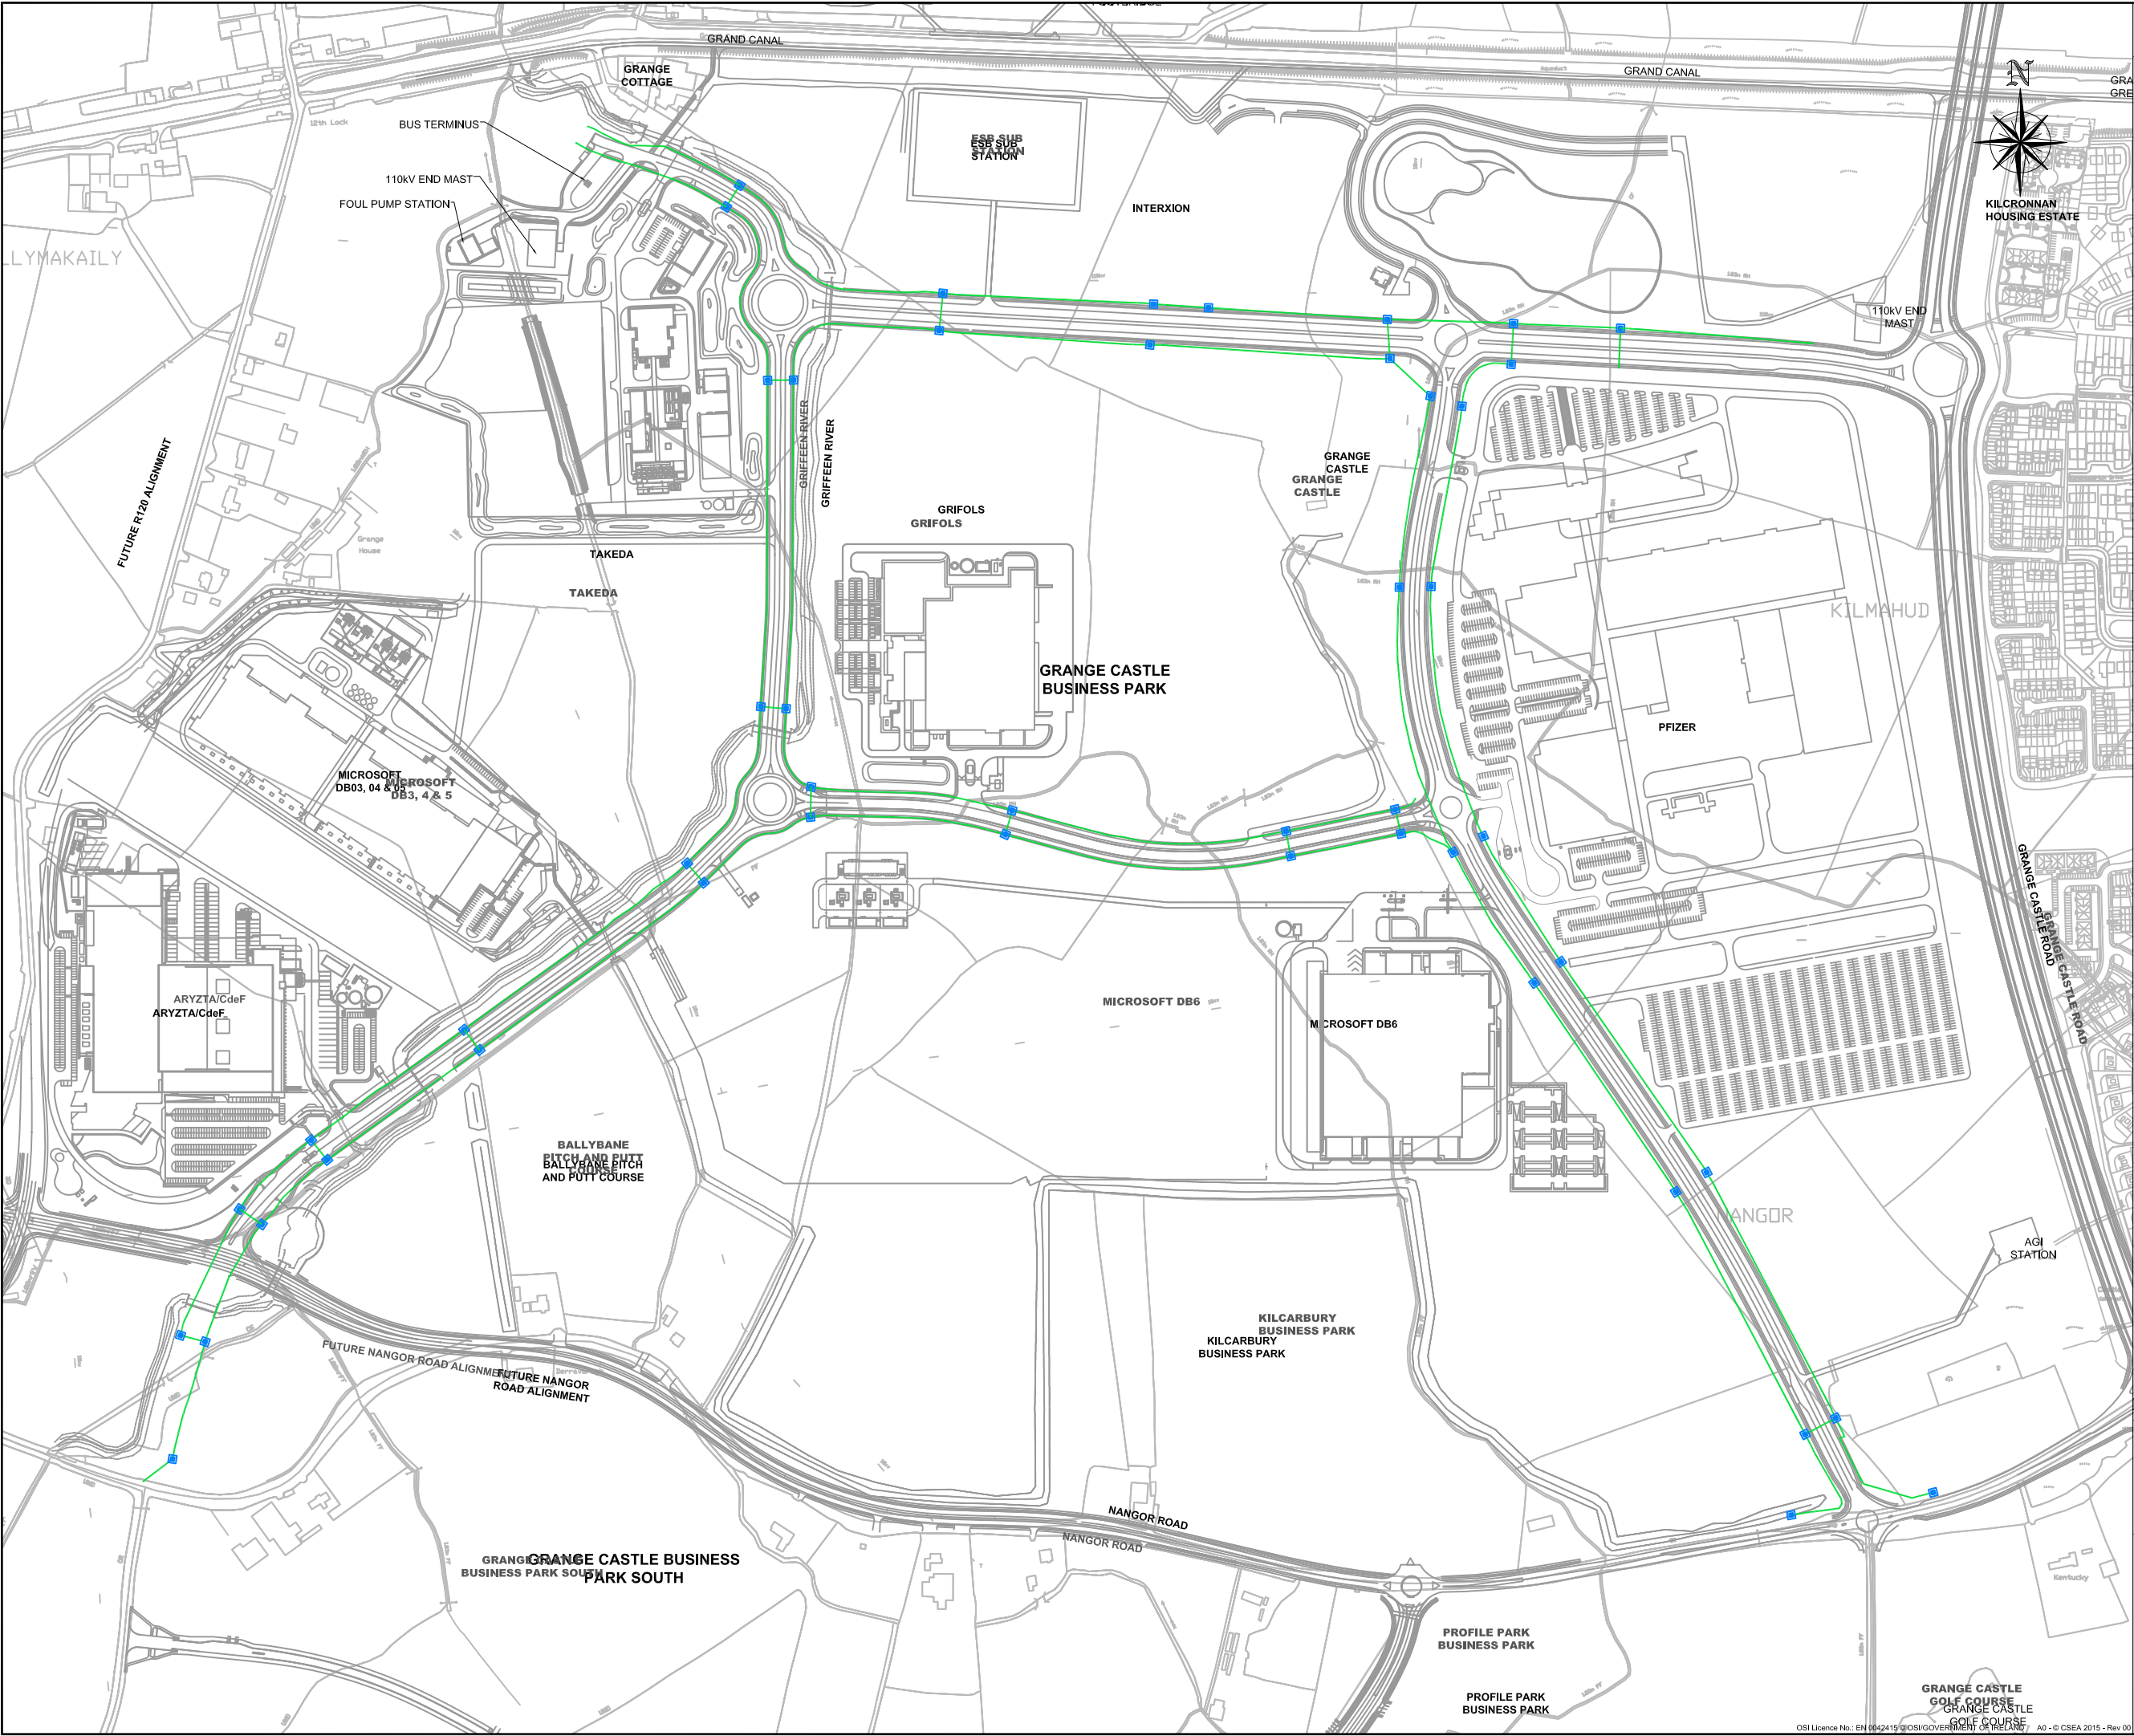

LEGEND:
TELECOM DUCTING AND CHAMBER 5
GRANGE CASTLE BUSINESS PARK
BOUNDARY

TOTAL LENGTH OF TELECOM DUCTING (CH5) 8669m

NOTE:
TELECOM DUCTING ON CENTRAL CARRIAGEWAY (CH5) 1102m

CH 1	SIROM	CH 1
CH 2	NOT IN USE	CH 2
CH 3	MICROSOFT	CH 3
CH 4	BRITISH TELECOMS	CH 4
CH 5	NOT IN USE	CH 5
CH 6	NOT IN USE	CH 6
CH 7	NOT IN USE	CH 7
CH 8	SOUTH DUBLIN COUNTY COUNCIL	CH 8
CHAMBER LAYOUT NTS		

A	CHAMBER 5 DUCTING AMENDED	KT	09/03/2016
---	---------------------------	----	------------

Revision

Description

Initials

Date

Clifton Scannell Emerson
Associates Limited
Consulting Engineers,
Seafort Lodge,
Castledareen Avenue,
Blackrock, Co. Dublin,
Ireland.
T: +353 1 288 5005
F: +353 1 283 3466
E: info@cses.ie
W: www.cses.ie

Client South Dublin County Council

Project Grange Castle Business Park
Telecom Layout
Chamber 5

Drawn By KT Date Dec, 2015

Checked by RG Scale 1:2000 @ A0

Drawn Progress

Drawn No 02_028D_1005 - A