


NOTES:

THIS DRAWING FOR INFORMATION ONLY. WHILE EVERY EFFORT HAS BEEN MADE TO ENSURE THAT THE SERVICES SHOWN ARE IN THE POSITIONS INDICATED ON THIS DRAWING, NO RESPONSIBILITY CAN BE TAKEN FOR DAMAGE OR INJURY CAUSED WHILE WORKING AT OR NEAR THE SERVICES.

WORK SHOULD PROCEED WITH EXTREME CARE AT ALL TIMES.

THIS DRAWING IS BELIEVED TO BE UP TO DATE AT THE TIME OF PRODUCTION. FURTHER SERVICES MAY HAVE BEEN ADDED SUBSEQUENT TO ISSUING OF DRAWINGS. USERS SHOULD OPERATE ON THE BASIS THAT SERVICES MAY HAVE BEEN ADDED WITHOUT RECORD.

NOTE : EXTERNAL SERVICES ONLY

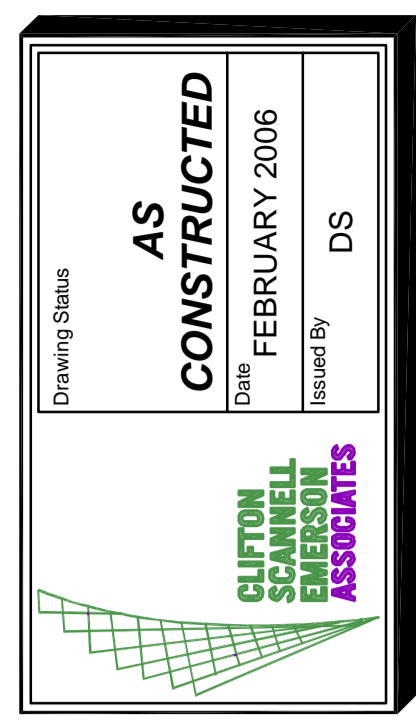


CLIFTON SCANNELL EMERSON ASSOCIATES
 Consulting Engineers, Architects, Planners, Surveyors
 100, 102, 104, 998, 1000

CLIFTON SCANNELL EMERSON ASSOCIATES

South Dublin County Council
 Grange Castle AS
 Built Drawings
 Overall Telecom Layout

Drawn By: DS/RG/KN Date: FEBRUARY 2006
 Checked By: PF Scale: 1/2000
 Drawing No.: 04_062/005

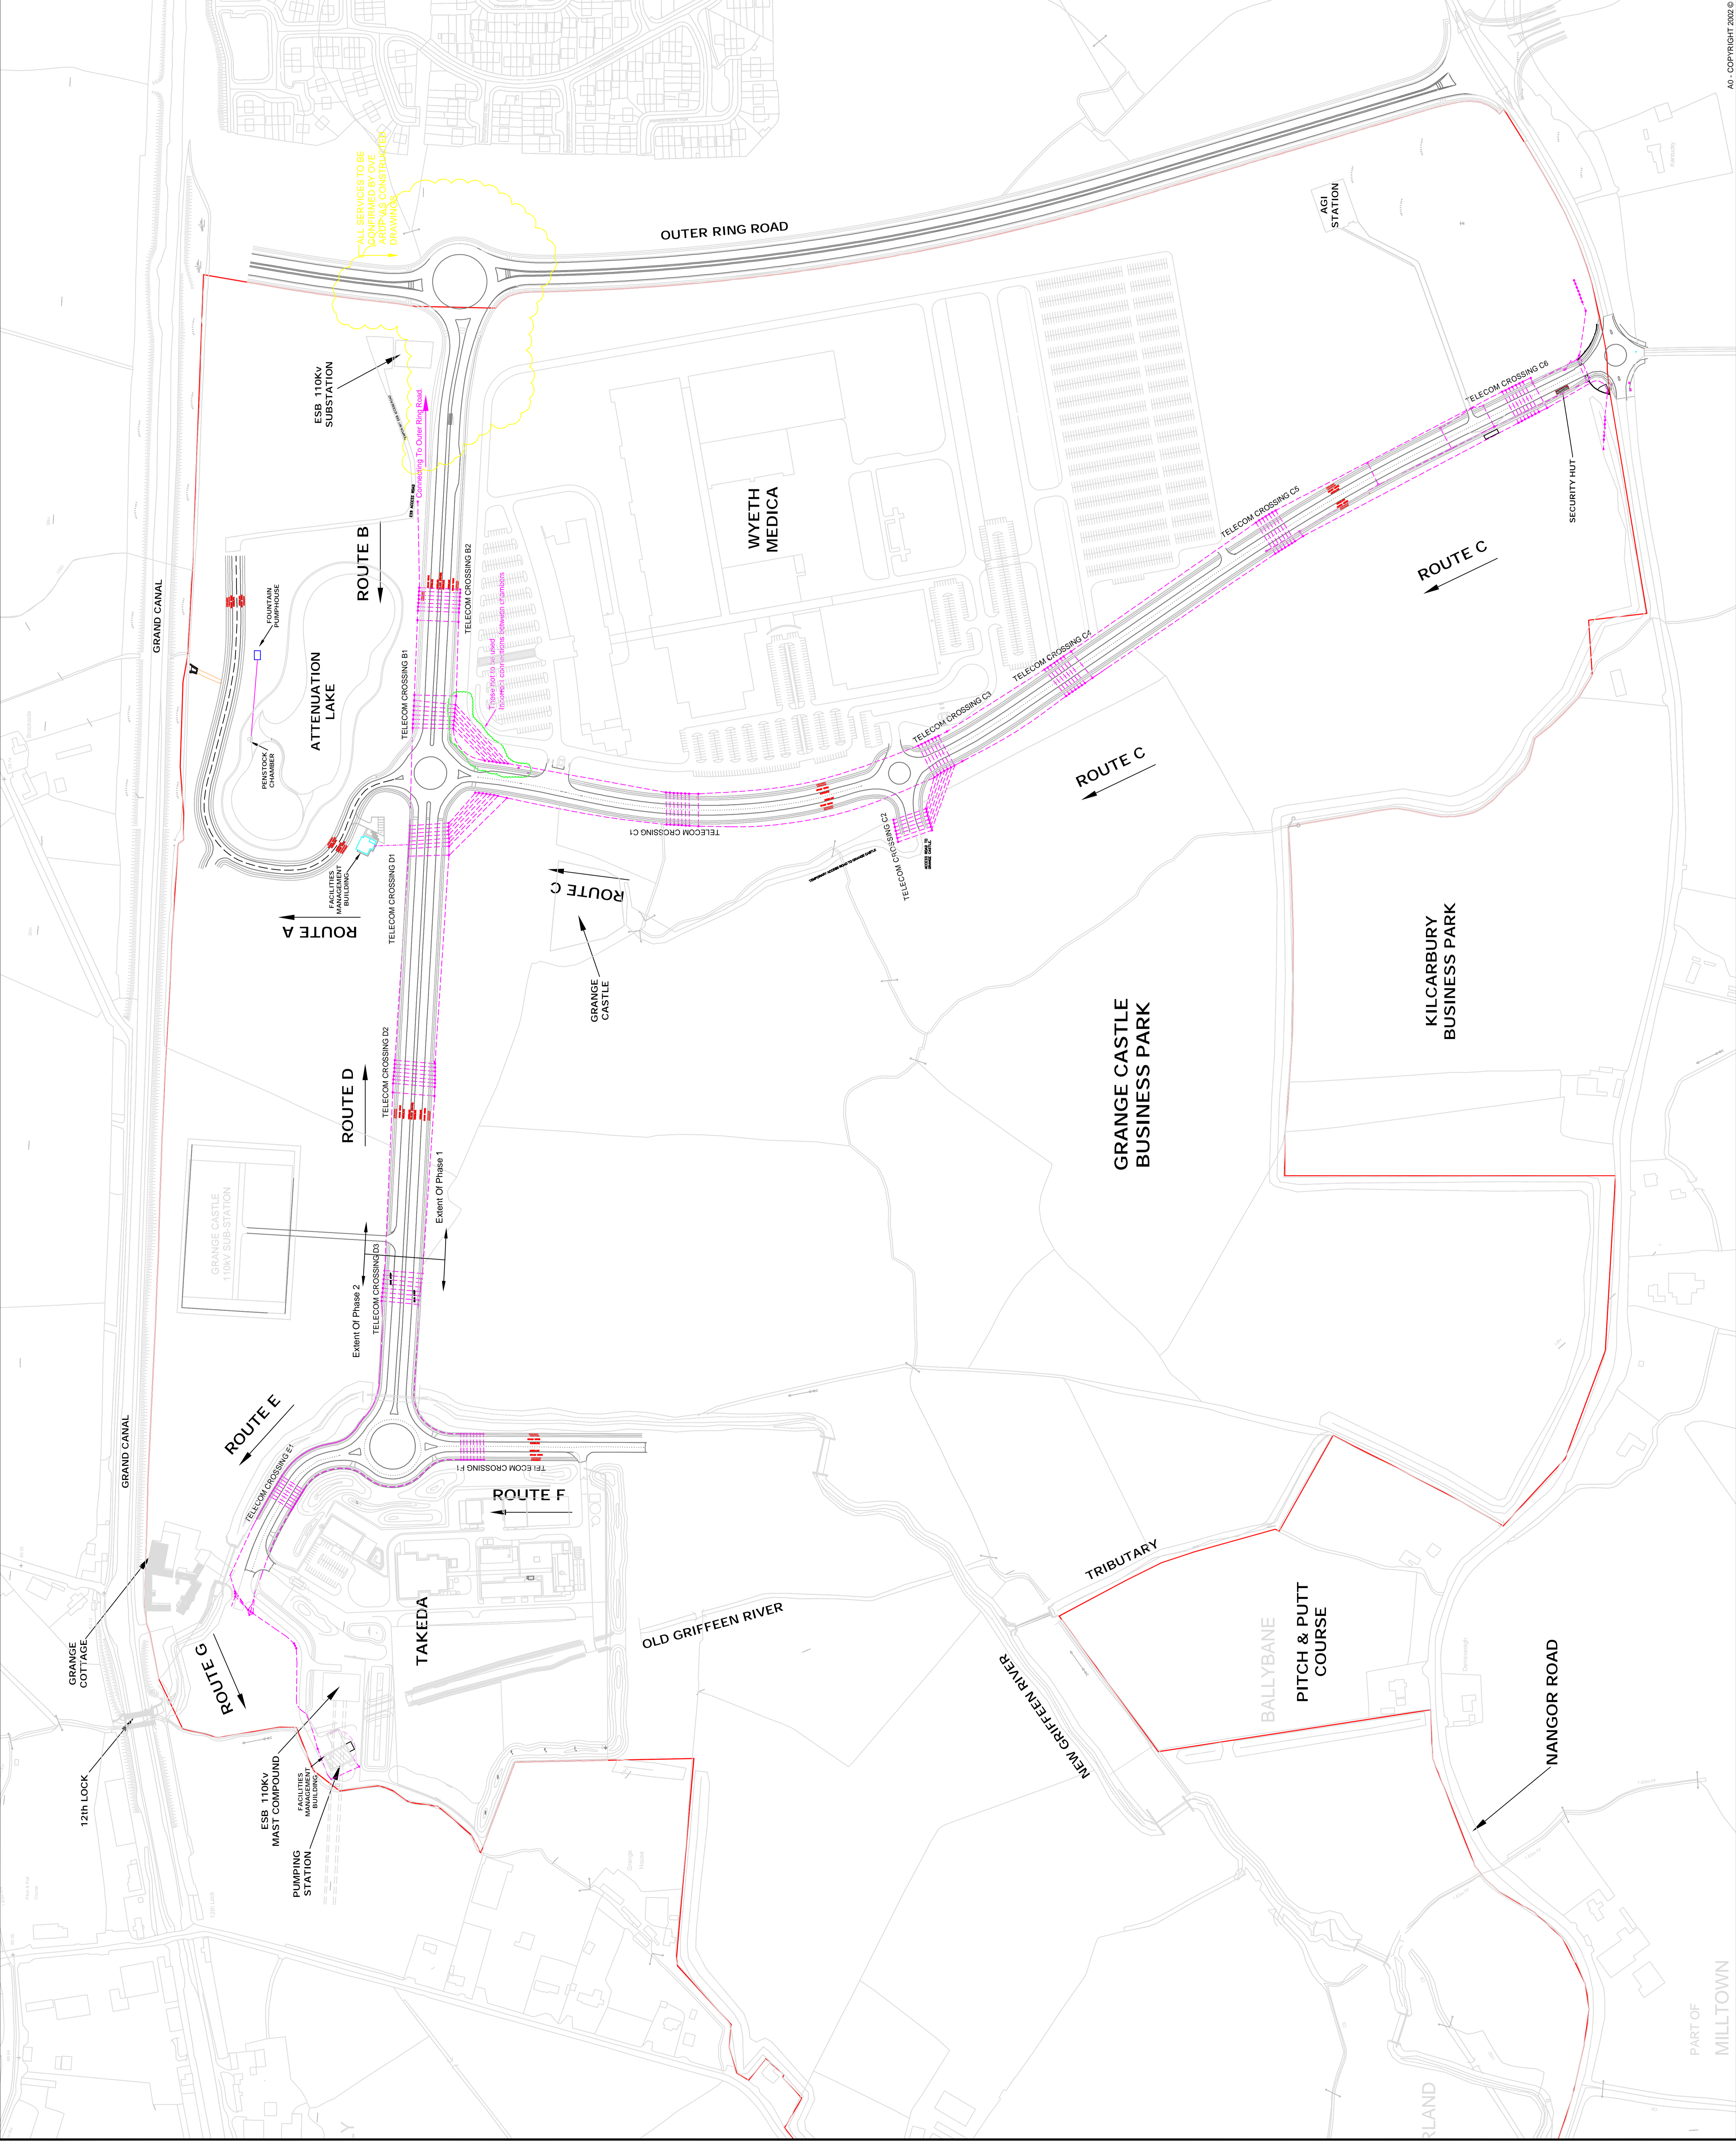

A0 - COPYRIGHT 2006 ©